

LEGEND Plumbing (By MEP Contractor)

AFF : After Finished Floor

○ : CW – COLD WATER supply connection w/ball valve

● : HW – HOT WATER supply connection w/ball valve

⊕ : WD – WASTE DRAIN

LEGEND Electrical (By MEP Contractor)

AFF : After Finished Floor

⌒ : SSO – Single phase socket outlet

⊞ : TPN – Three phase + neutral + ground (Selector switch)

⊞ : SPN – Single phase + neutral + ground (Selector switch)

⊙ : PS – Power switch


Ⓒ : C0 – Cable outlet single phase w/ cable length

Ⓒⓓ : C03 – Cable outlet three phase + neutral + ground w/ cable length

LEGEND Gas (By GAS Contractor)

AFF : After Finished Floor

▲ : GS – Gas supply w/ball valve

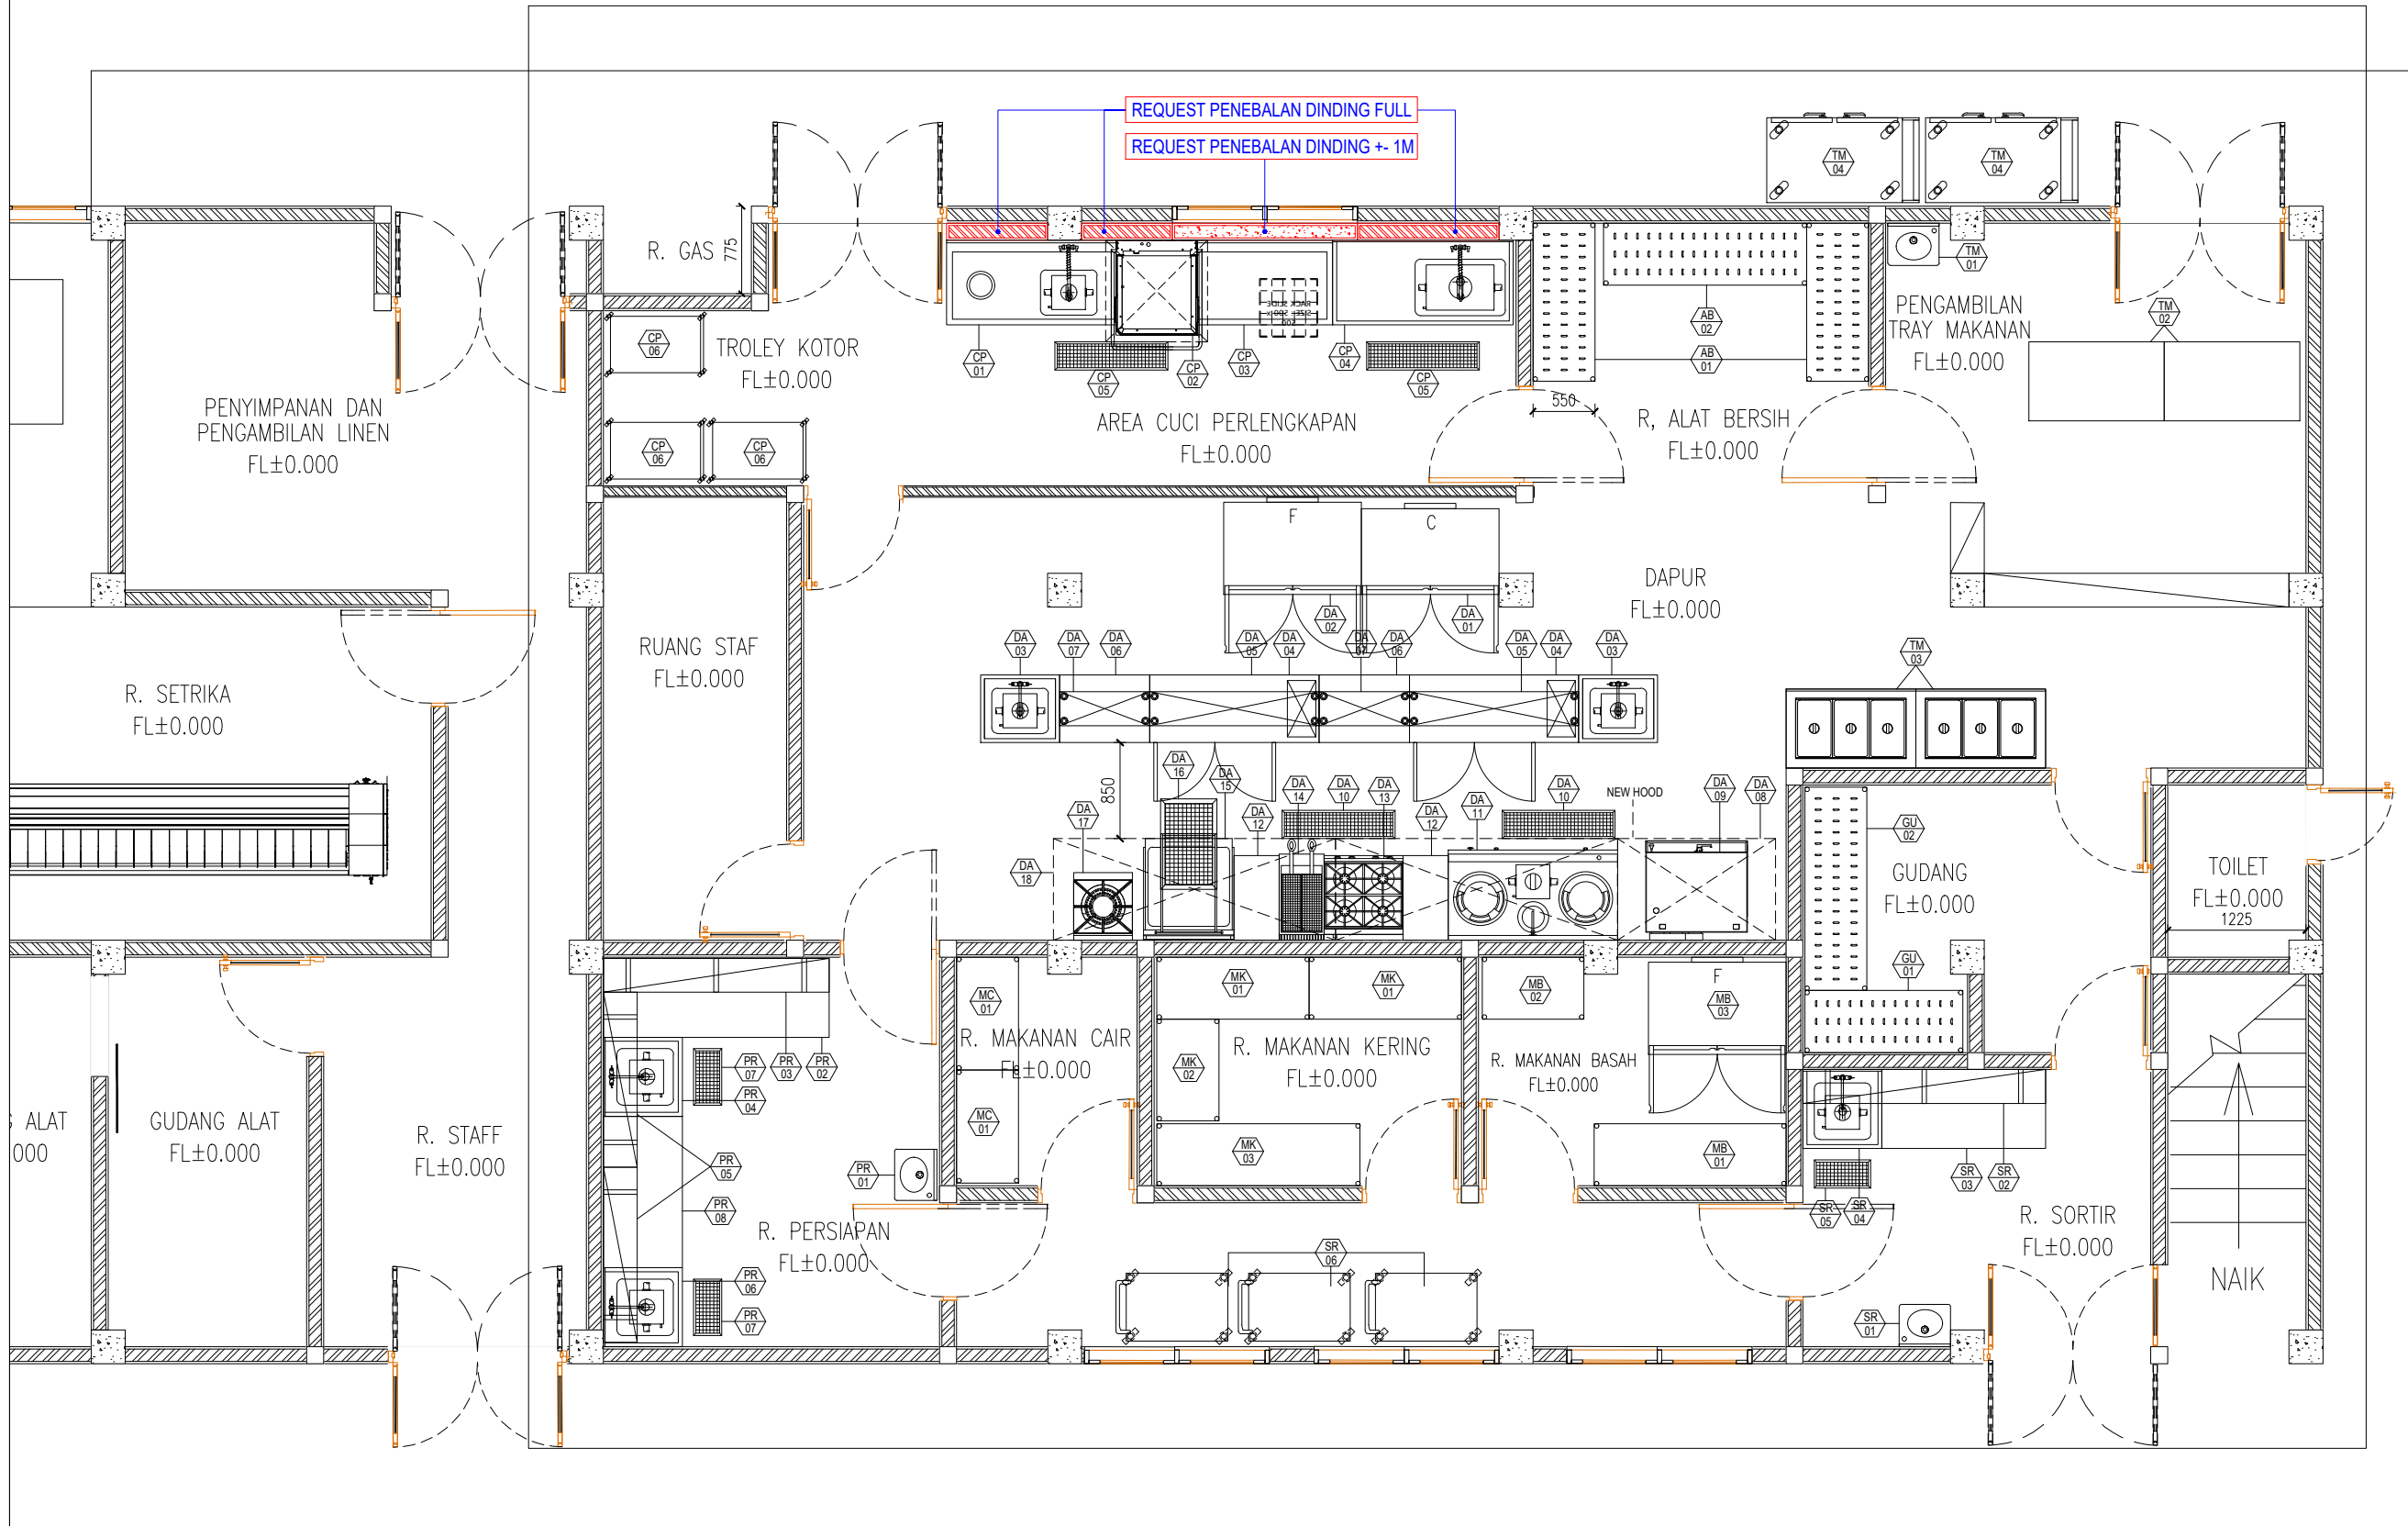

PT. Butik Kitchen Indonesia


Date : 21 Desember 2022

Title : LAYOUT KITCHEN PLAN
RS HASTIEN HUSADA, CIKANGKUNG

R2

Drawn By,

AR

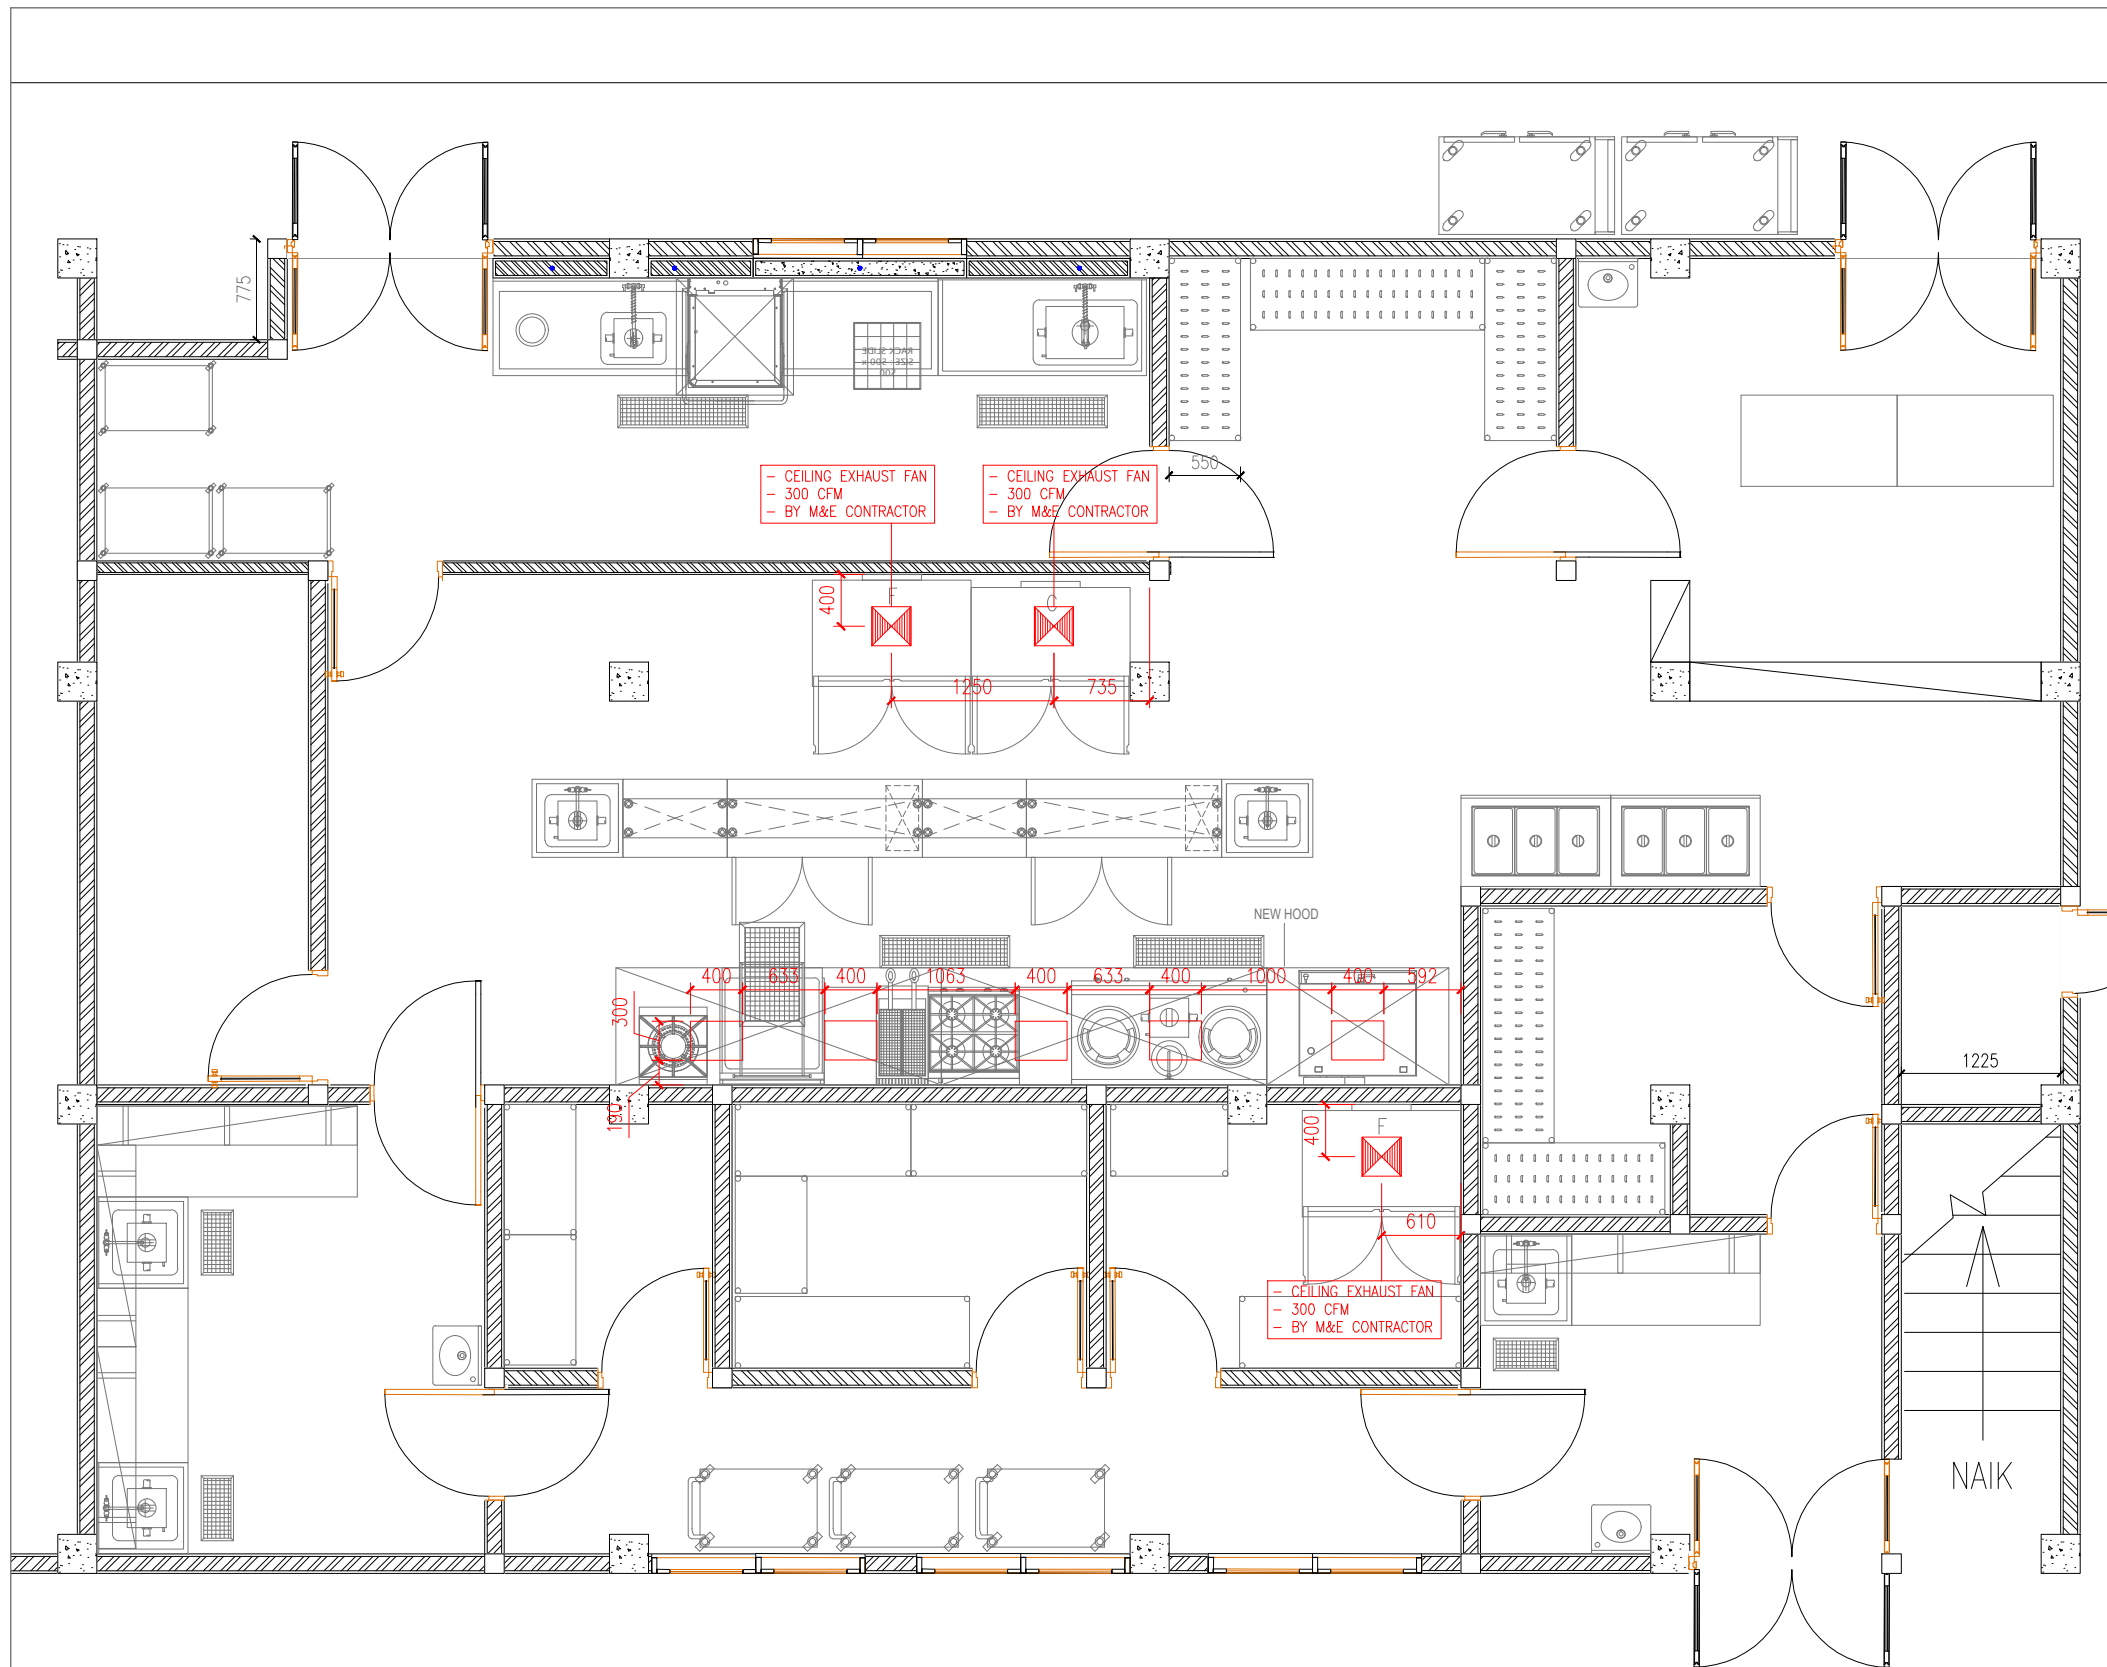


PT. Butik Kitchen Indonesia

Date : 21 Desember 2022

Title : EXHAUST PLAN
RS HASTIEN HUSADA, CIKANGKUNG

Drawn By,

AR

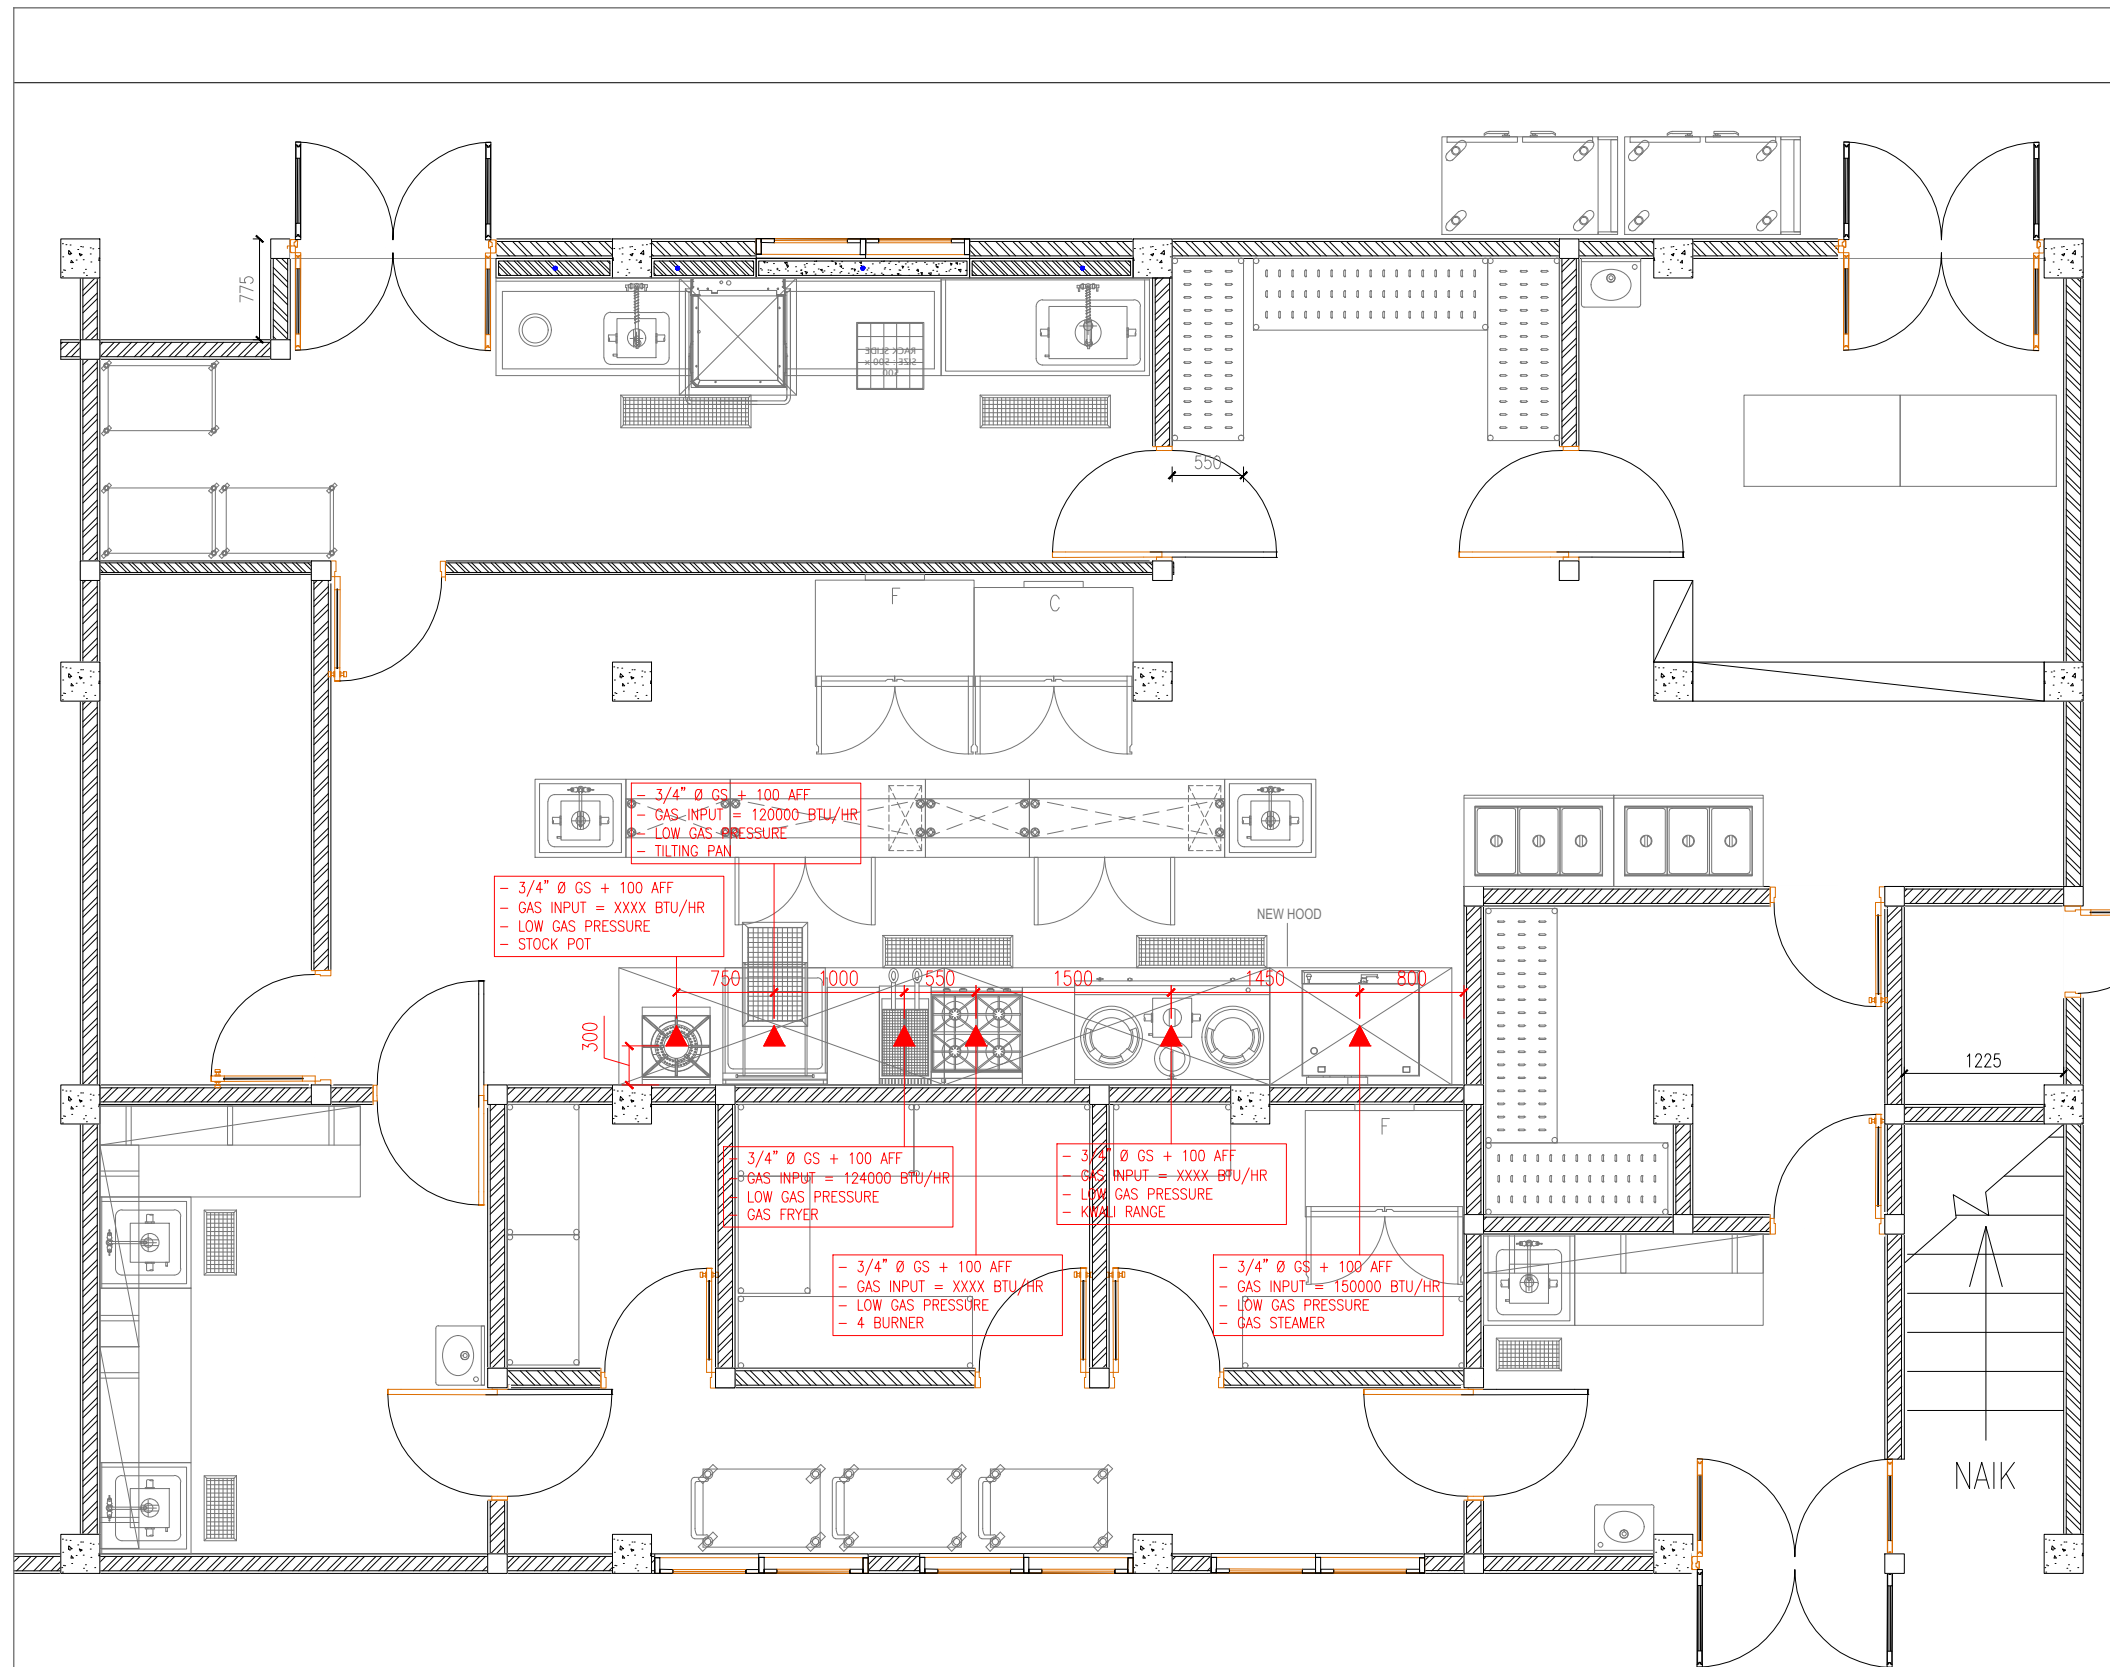


PT. Butik Kitchen Indonesia

Date : 21 Desember 2022

Drawn By,

Title : GAS PLAN
RS HASTIEN HUSADA, CIKANGKUNG

AR

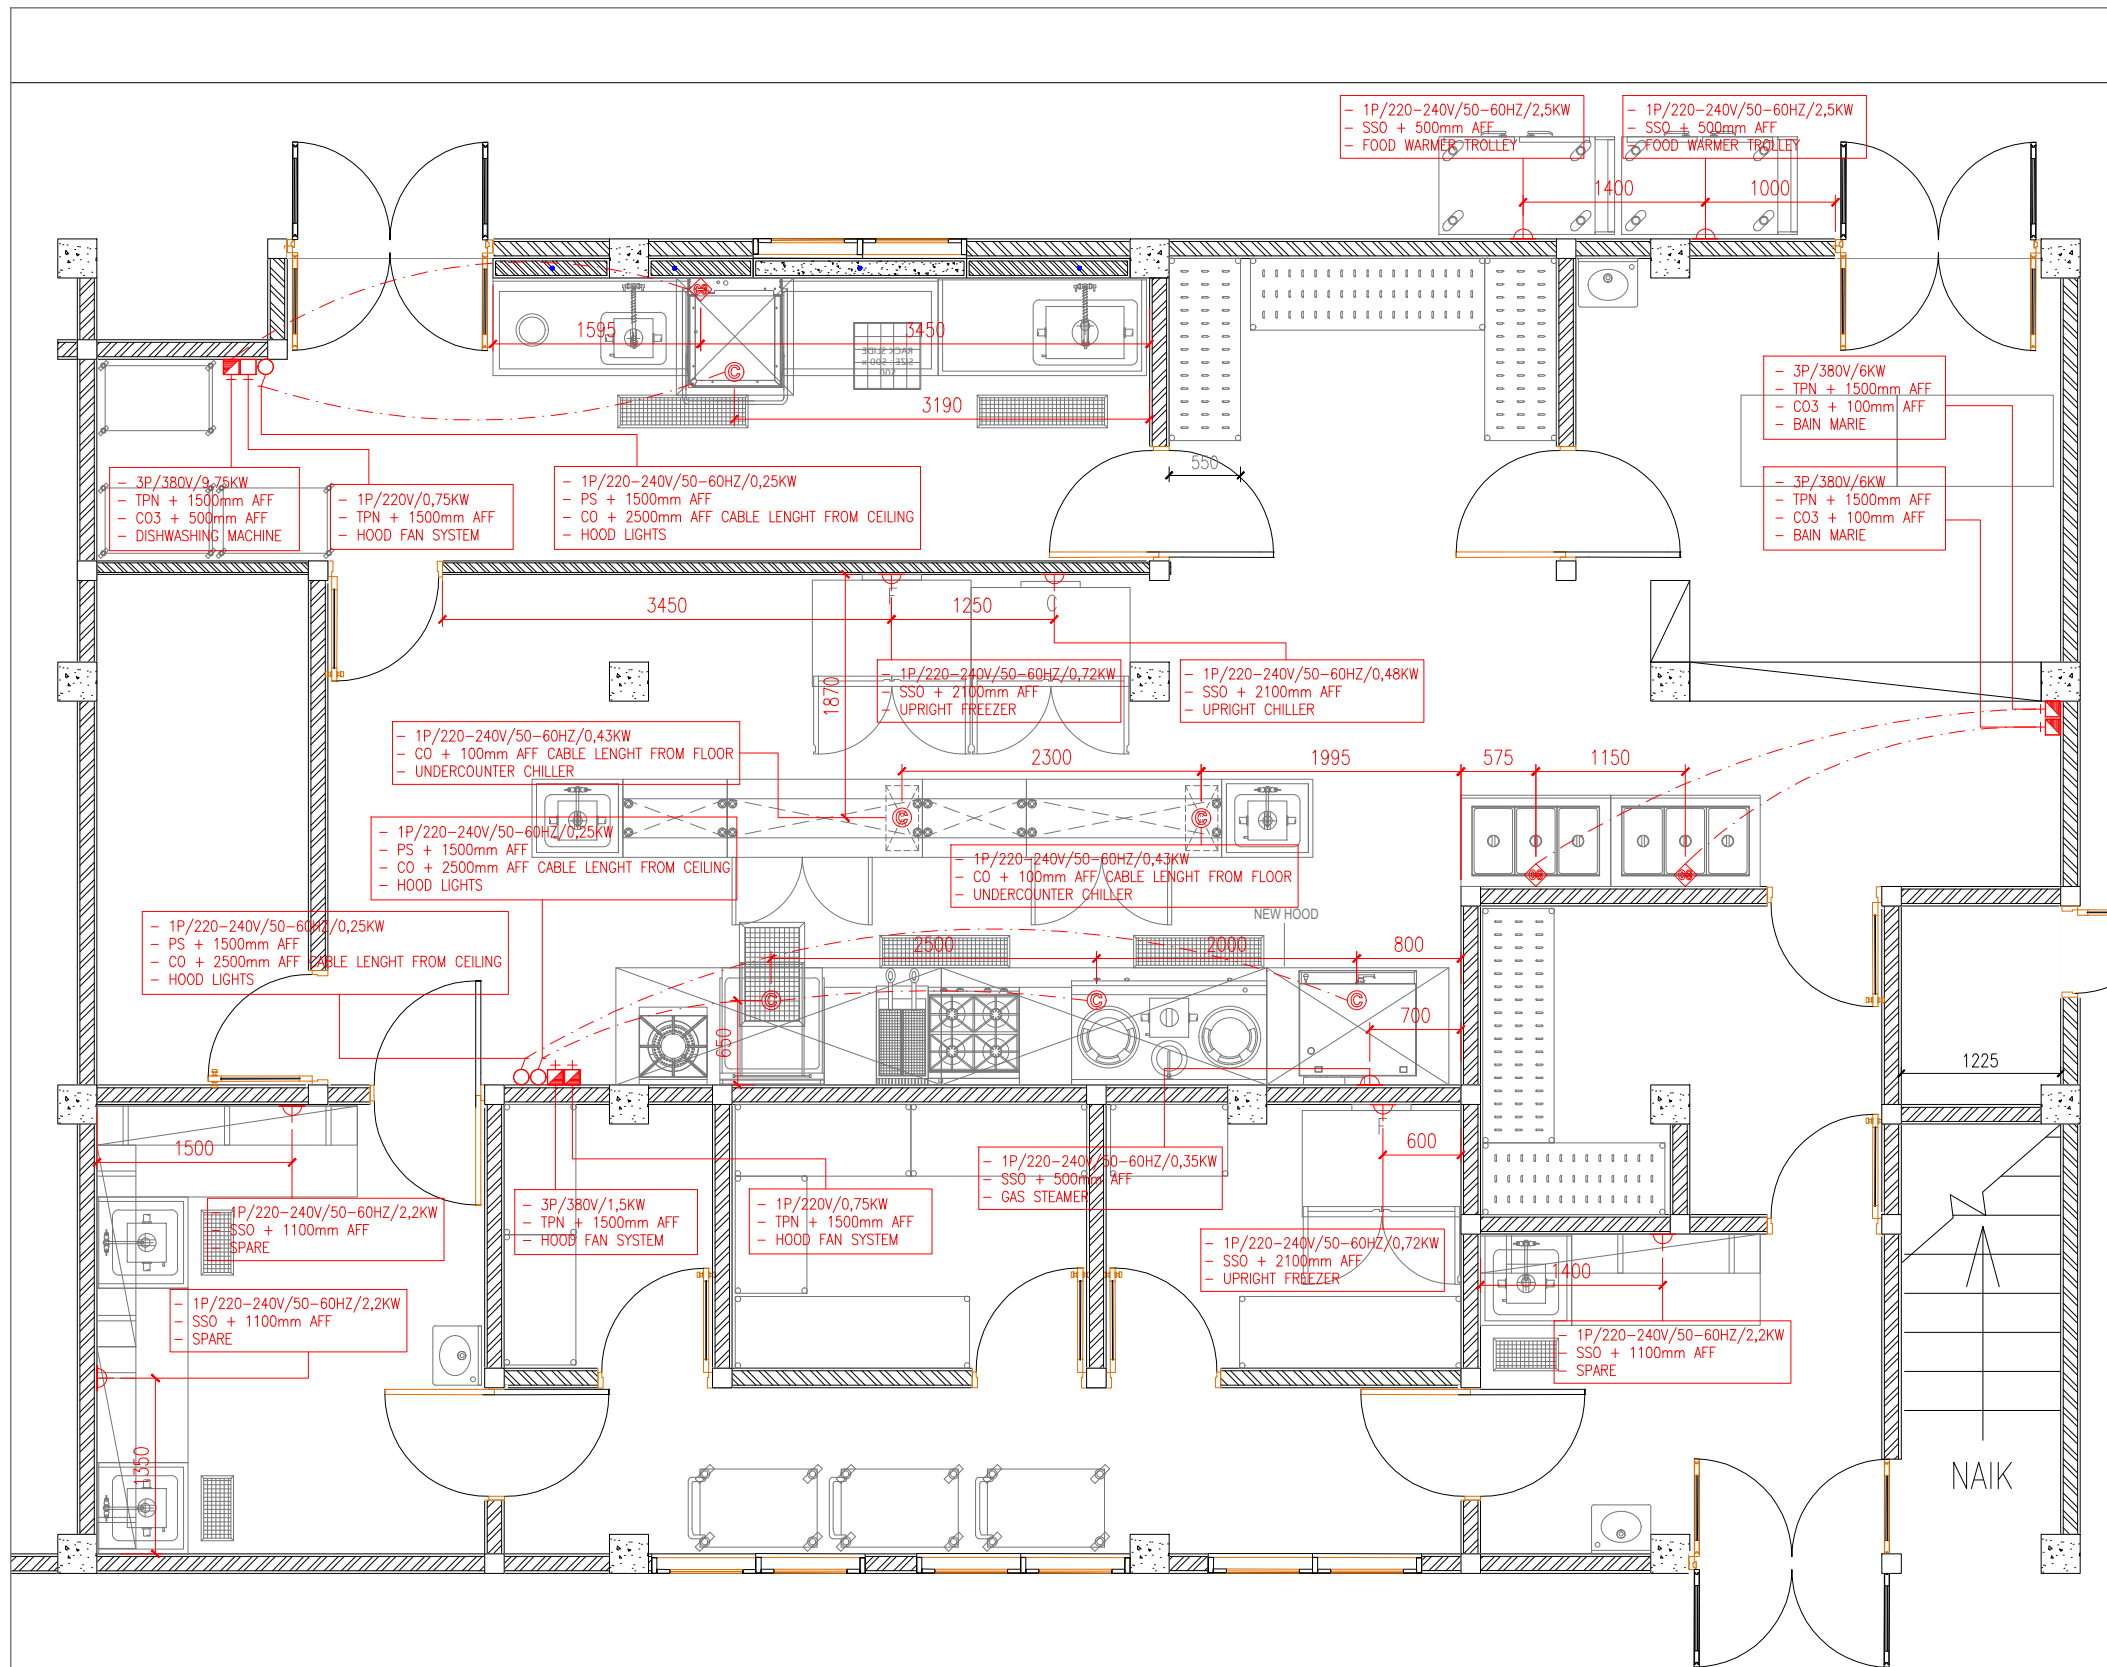

PT. Butik Kitchen Indonesia

Date : 21 Desember 2022

Title : ELECTRICAL PLAN
RS HASTIEN HUSADA, CIKANGKUNG

Drawn By,

AR